

INTRACORP DESIGN STUDIO

DRAWN BY: MARLENE BOURQUE

LARCHWOOD

ELECTRICAL PLAN - LOWER FLOOR

CLIENT:

Unit # 17 - Pak


DATE:

April 18, 2000

SCALE:

Handwritten initials or signature in the top right corner.

PATIO

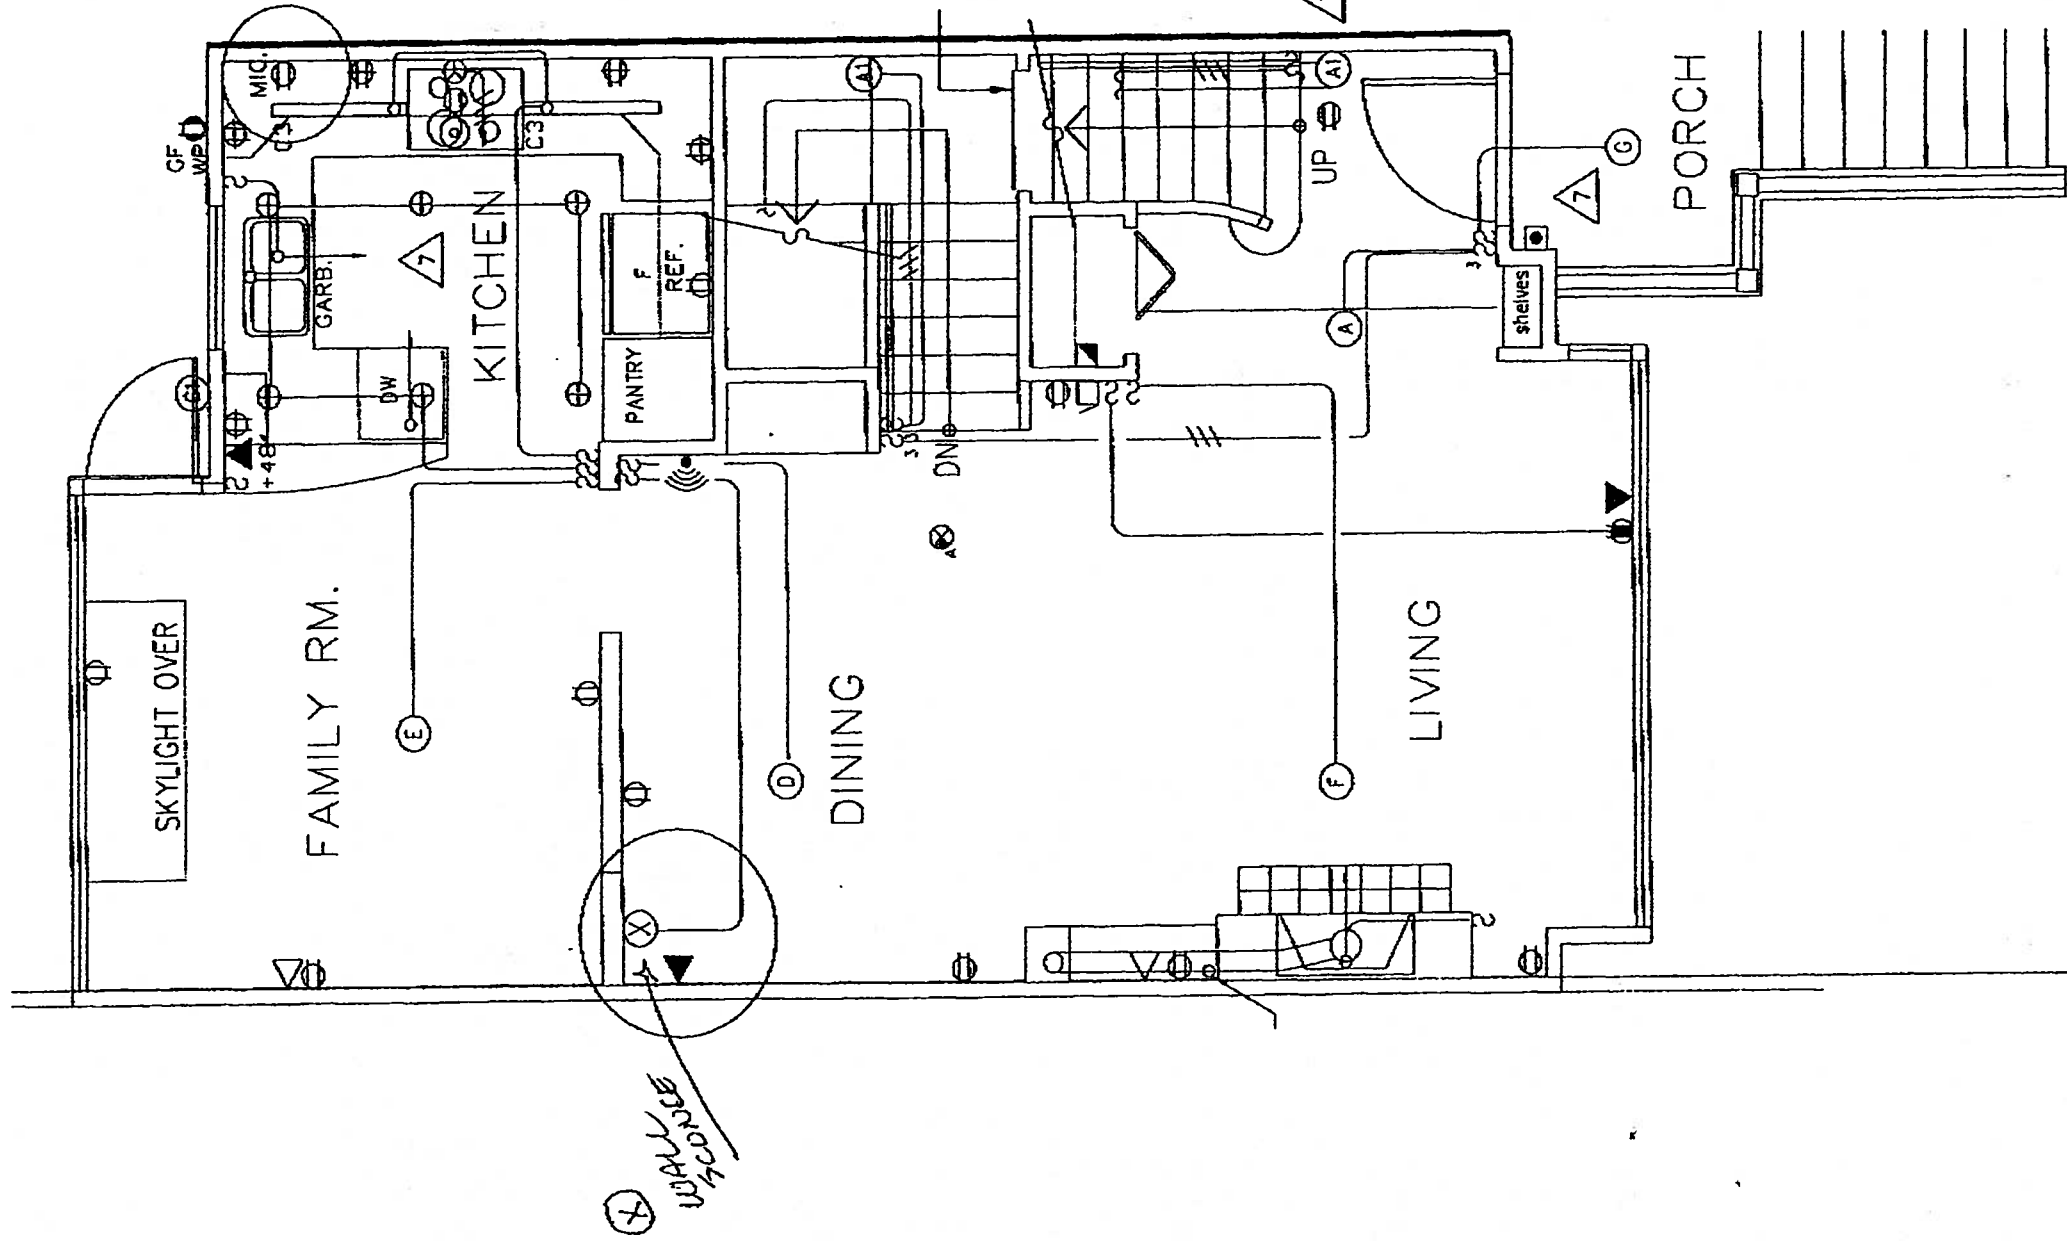

INTRACORP DESIGN STUDIO

DRAWN BY: MARLENE BOURQUE


MAIN

ELECTRICAL PLAN - ~~LOWER~~ FLOOR

CLIENT: Unit # 17 - Pak

DATE: April 18, 2000

SCALE:

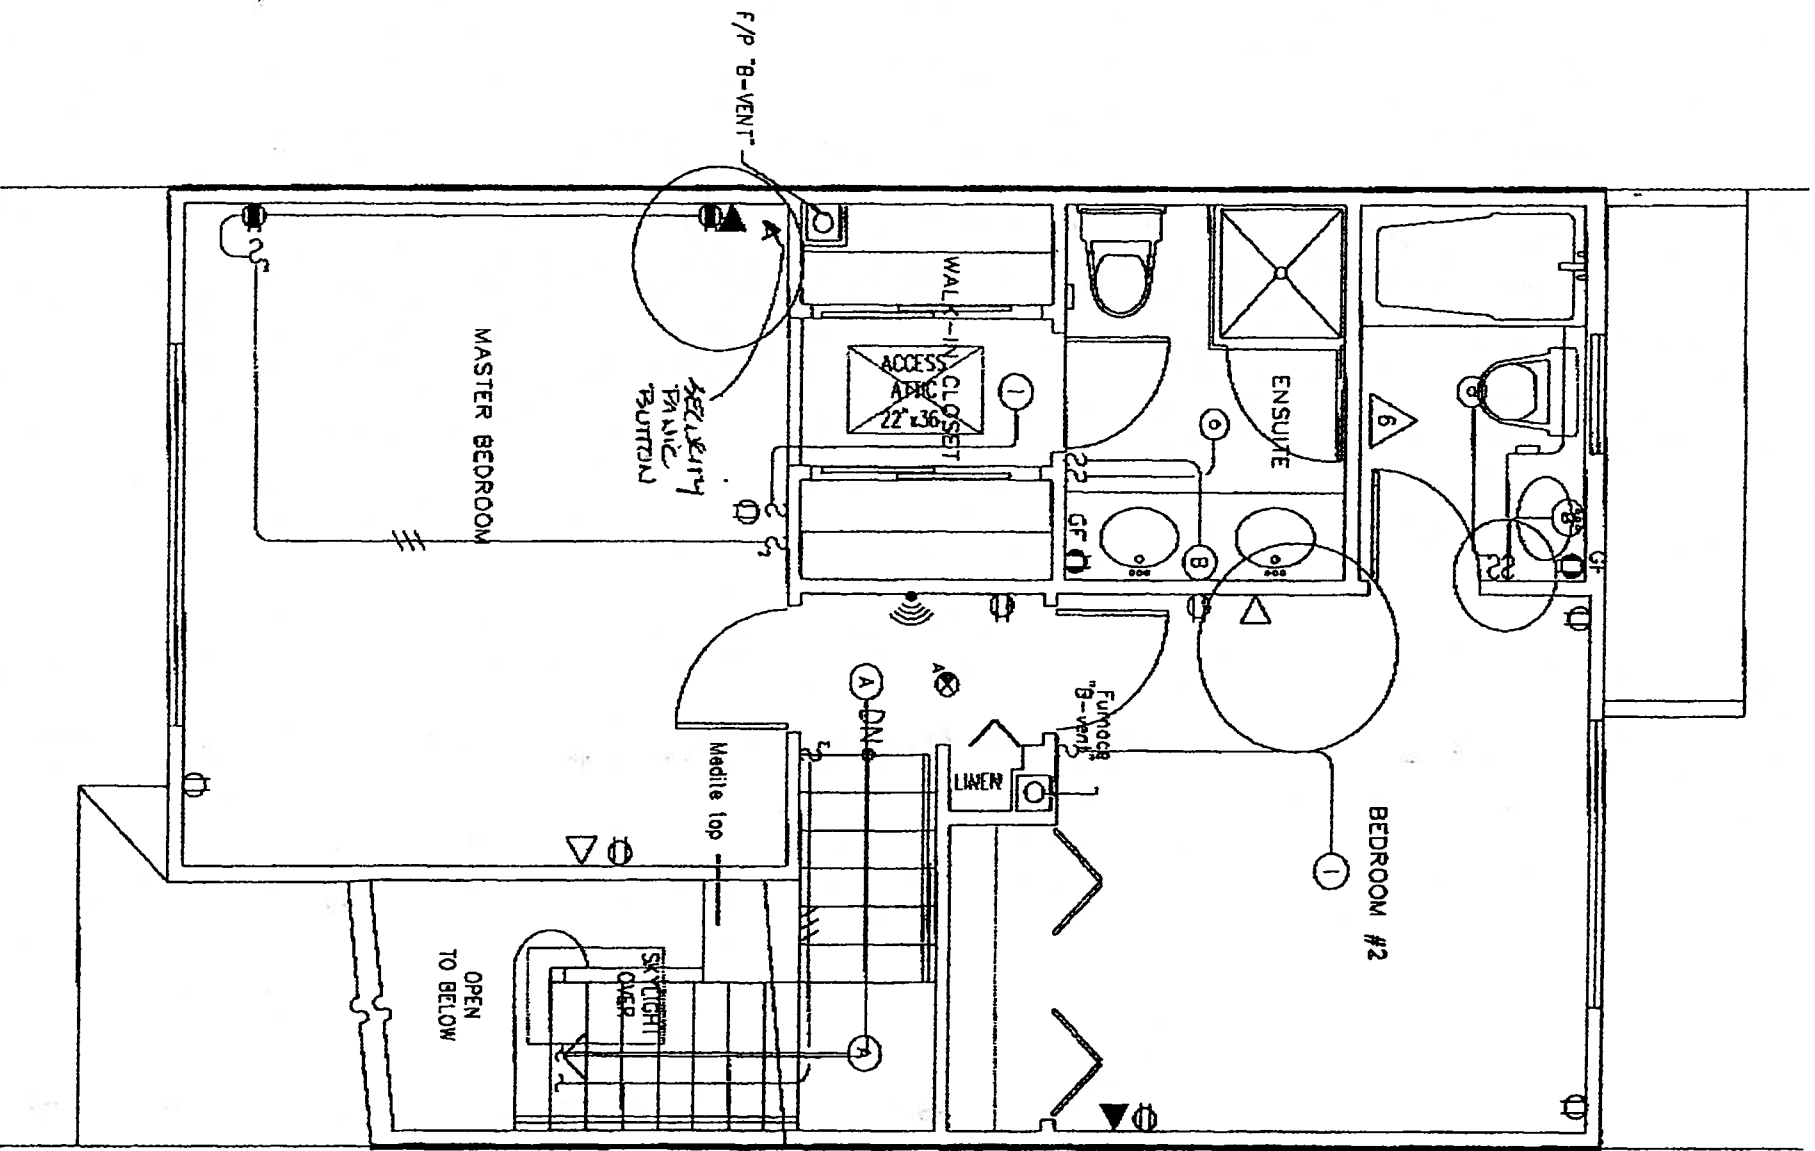

Handwritten initials and a checkmark.

INTRACORP DESIGN STUDIO

DRAWN BY: MARLENE BOJICIC

LARCHWOOD	ELECTRICAL PLAN - UPPER FLOOR
CLIENT:	Unit # 17 - Pak
DATE:	April 18, 2000
	SCALE: